


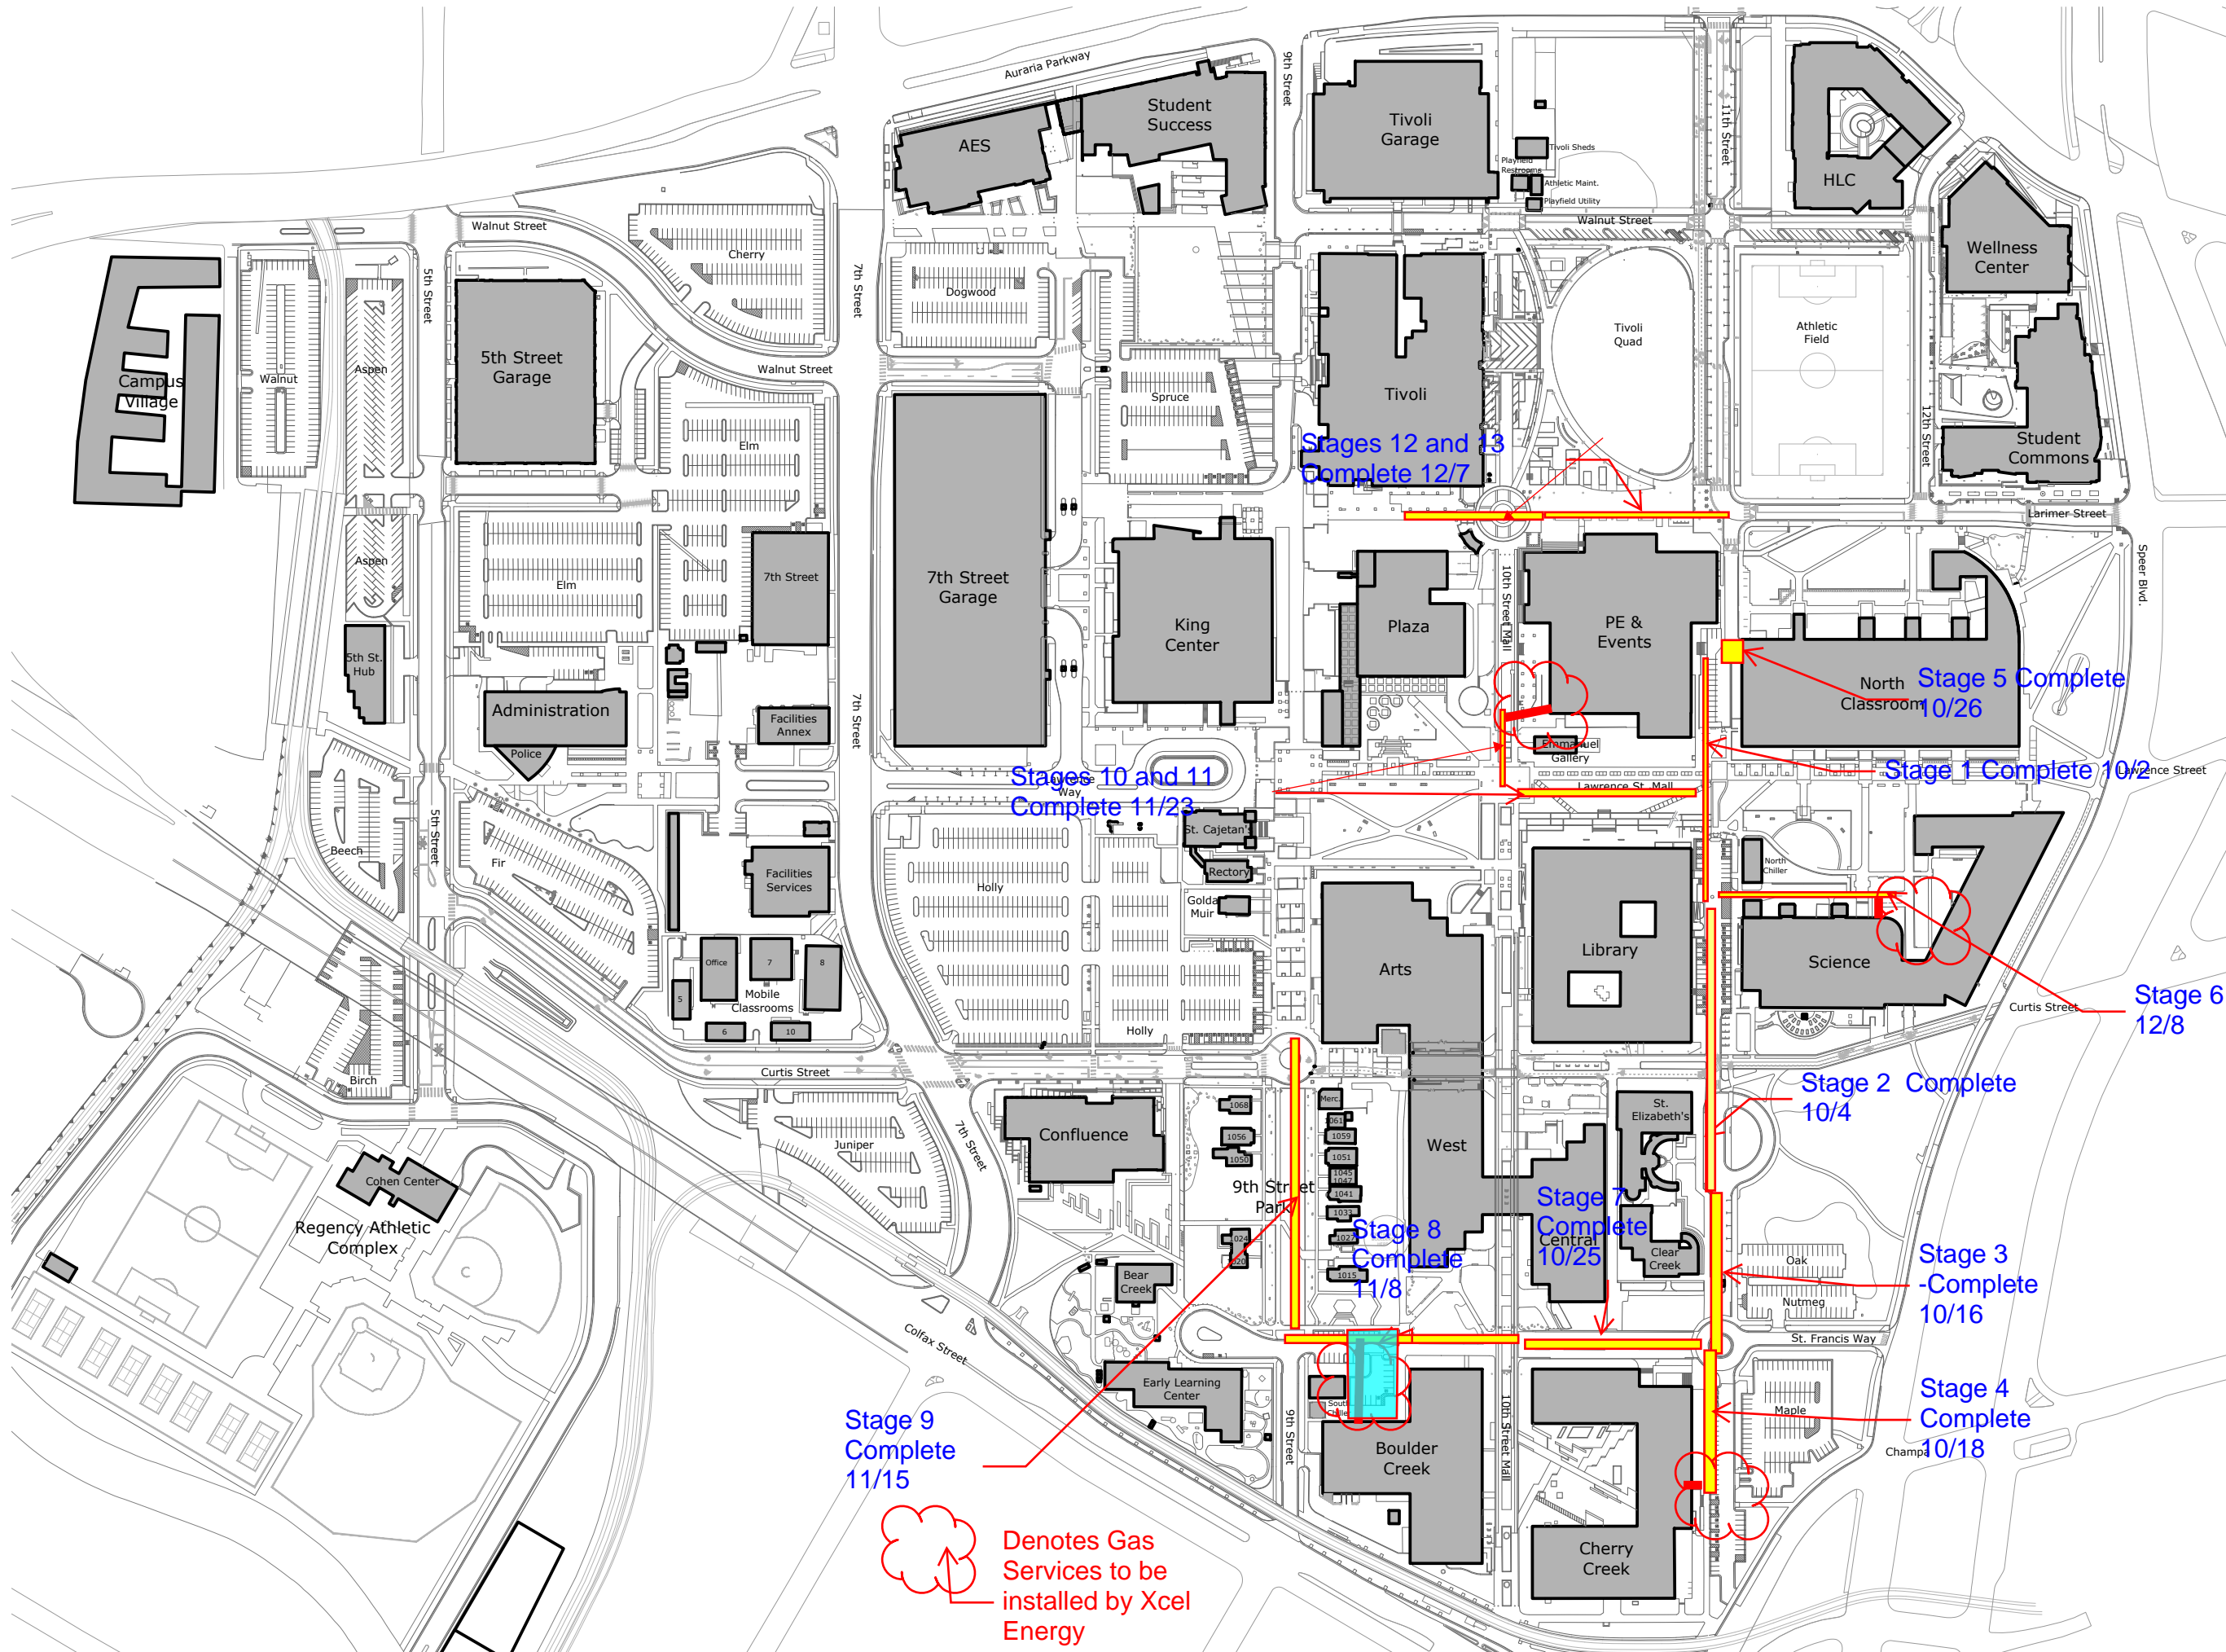

AURARIA HIGHER EDUCATION CENTER

DENVER, COLORADO

SITE: CAMPUS SITE PLAN



Stage 9
Complete
11/15

 Denotes Gas Services to be installed by Xcel Energy

Stages 12 and 13
Complete 12/7

Stages 10 and 11
Complete 11/23

Stage 5 Complete
10/26

Stage 1 Complete 10/2

Stage 6 Complete
12/8

Stage 2 Complete
10/4

Stage 8
Complete
11/8

Stage 7
Complete
10/25

Stage 3
-Complete
10/16

Stage 4
Complete
10/18

ISSUED: 9/19/18
REVISION RECORD:



SCALE: NTS